



**PLANNING & CAMPUS DEVELOPMENT**  
OFFICE OF SPACE MANAGEMENT

TOTAL FLOORS: 2  
TOTAL GROSS SQUARE FEET: 8,656  
FLOOR: 1  
GROSS SQUARE FEET: ?

MAIN ENTRANCE

SECONDARY ENTRANCE


**ZETA TAU ALPHA SORORITY HOUSE**  
FIRST FLOOR

1825 SIGMA CHI ROAD NE

#177

1 OF 2  
177-00-01

**FIRST FLOOR**  
SCALE: NOT TO SCALE

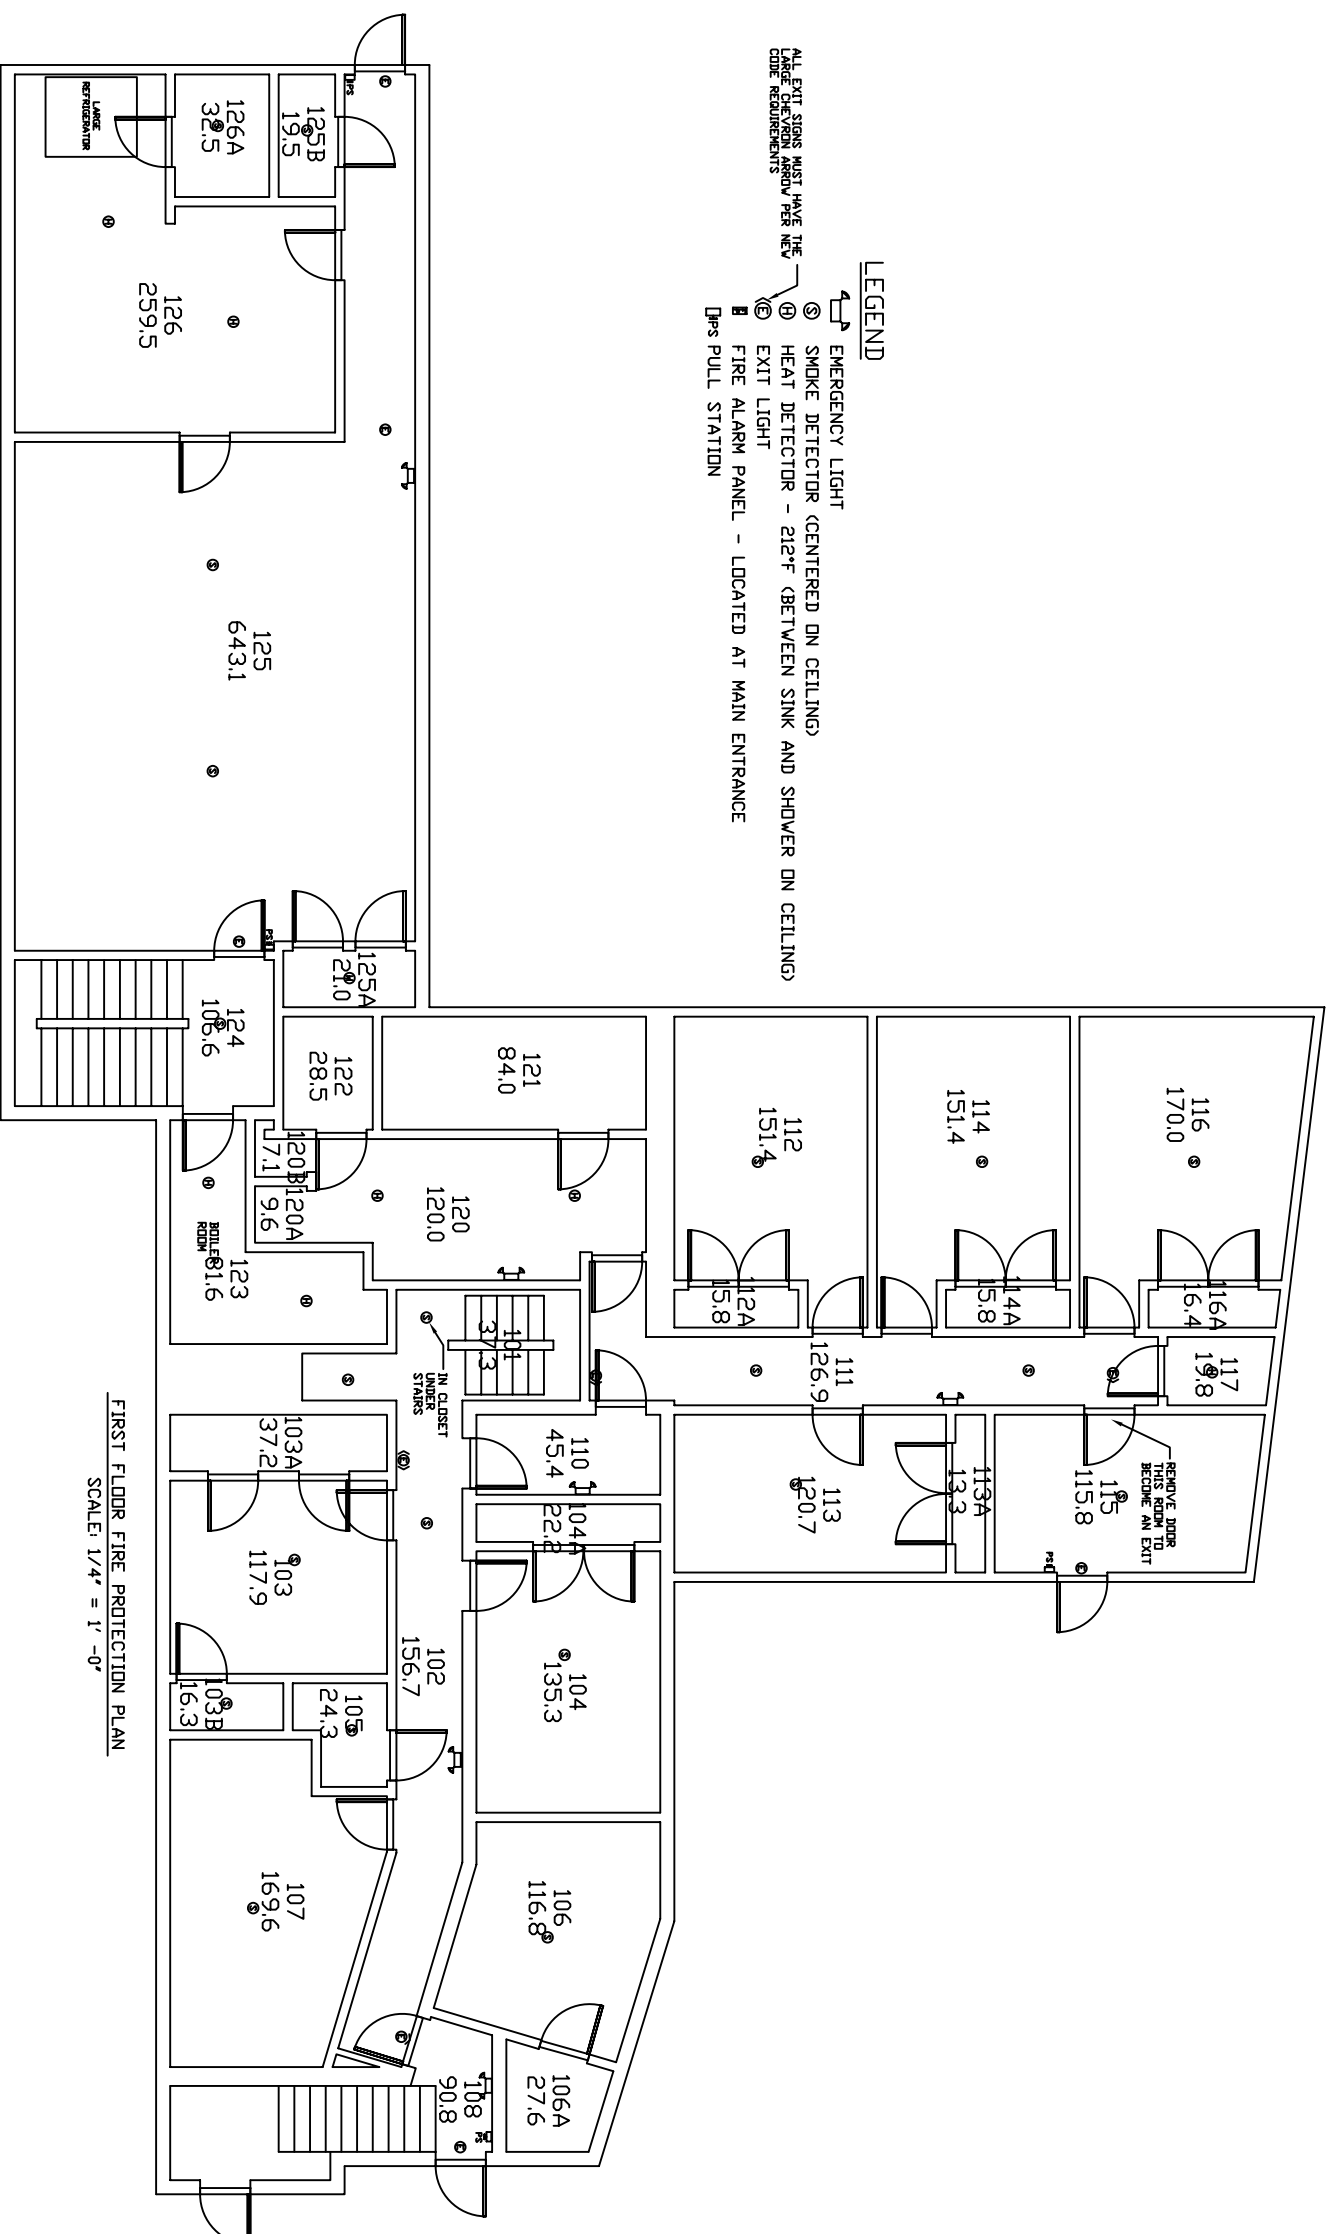

FIRST FLOOR FIRE PROTECTION PLAN  
SCALE: 1/4" = 1' - 0"