



**PLANNING & CAMPUS DEVELOPMENT**  
OFFICE OF SPACE MANAGEMENT

TOTAL FLOORS: 2 FLOOR: SECOND  
TOTAL GROSS SQUARE FEET: 8,656 GROSS SQUARE FEET: ?

MAIN ENTRANCE

SECONDARY ENTRANCE


**ZETA TAU ALPHA SORORITY HOUSE**  
SECOND FLOOR

1825 SIGMA CHI ROAD NE

#177

2 OF 2  
177-00-02

**SECOND FLOOR**  
SCALE: NOT TO SCALE

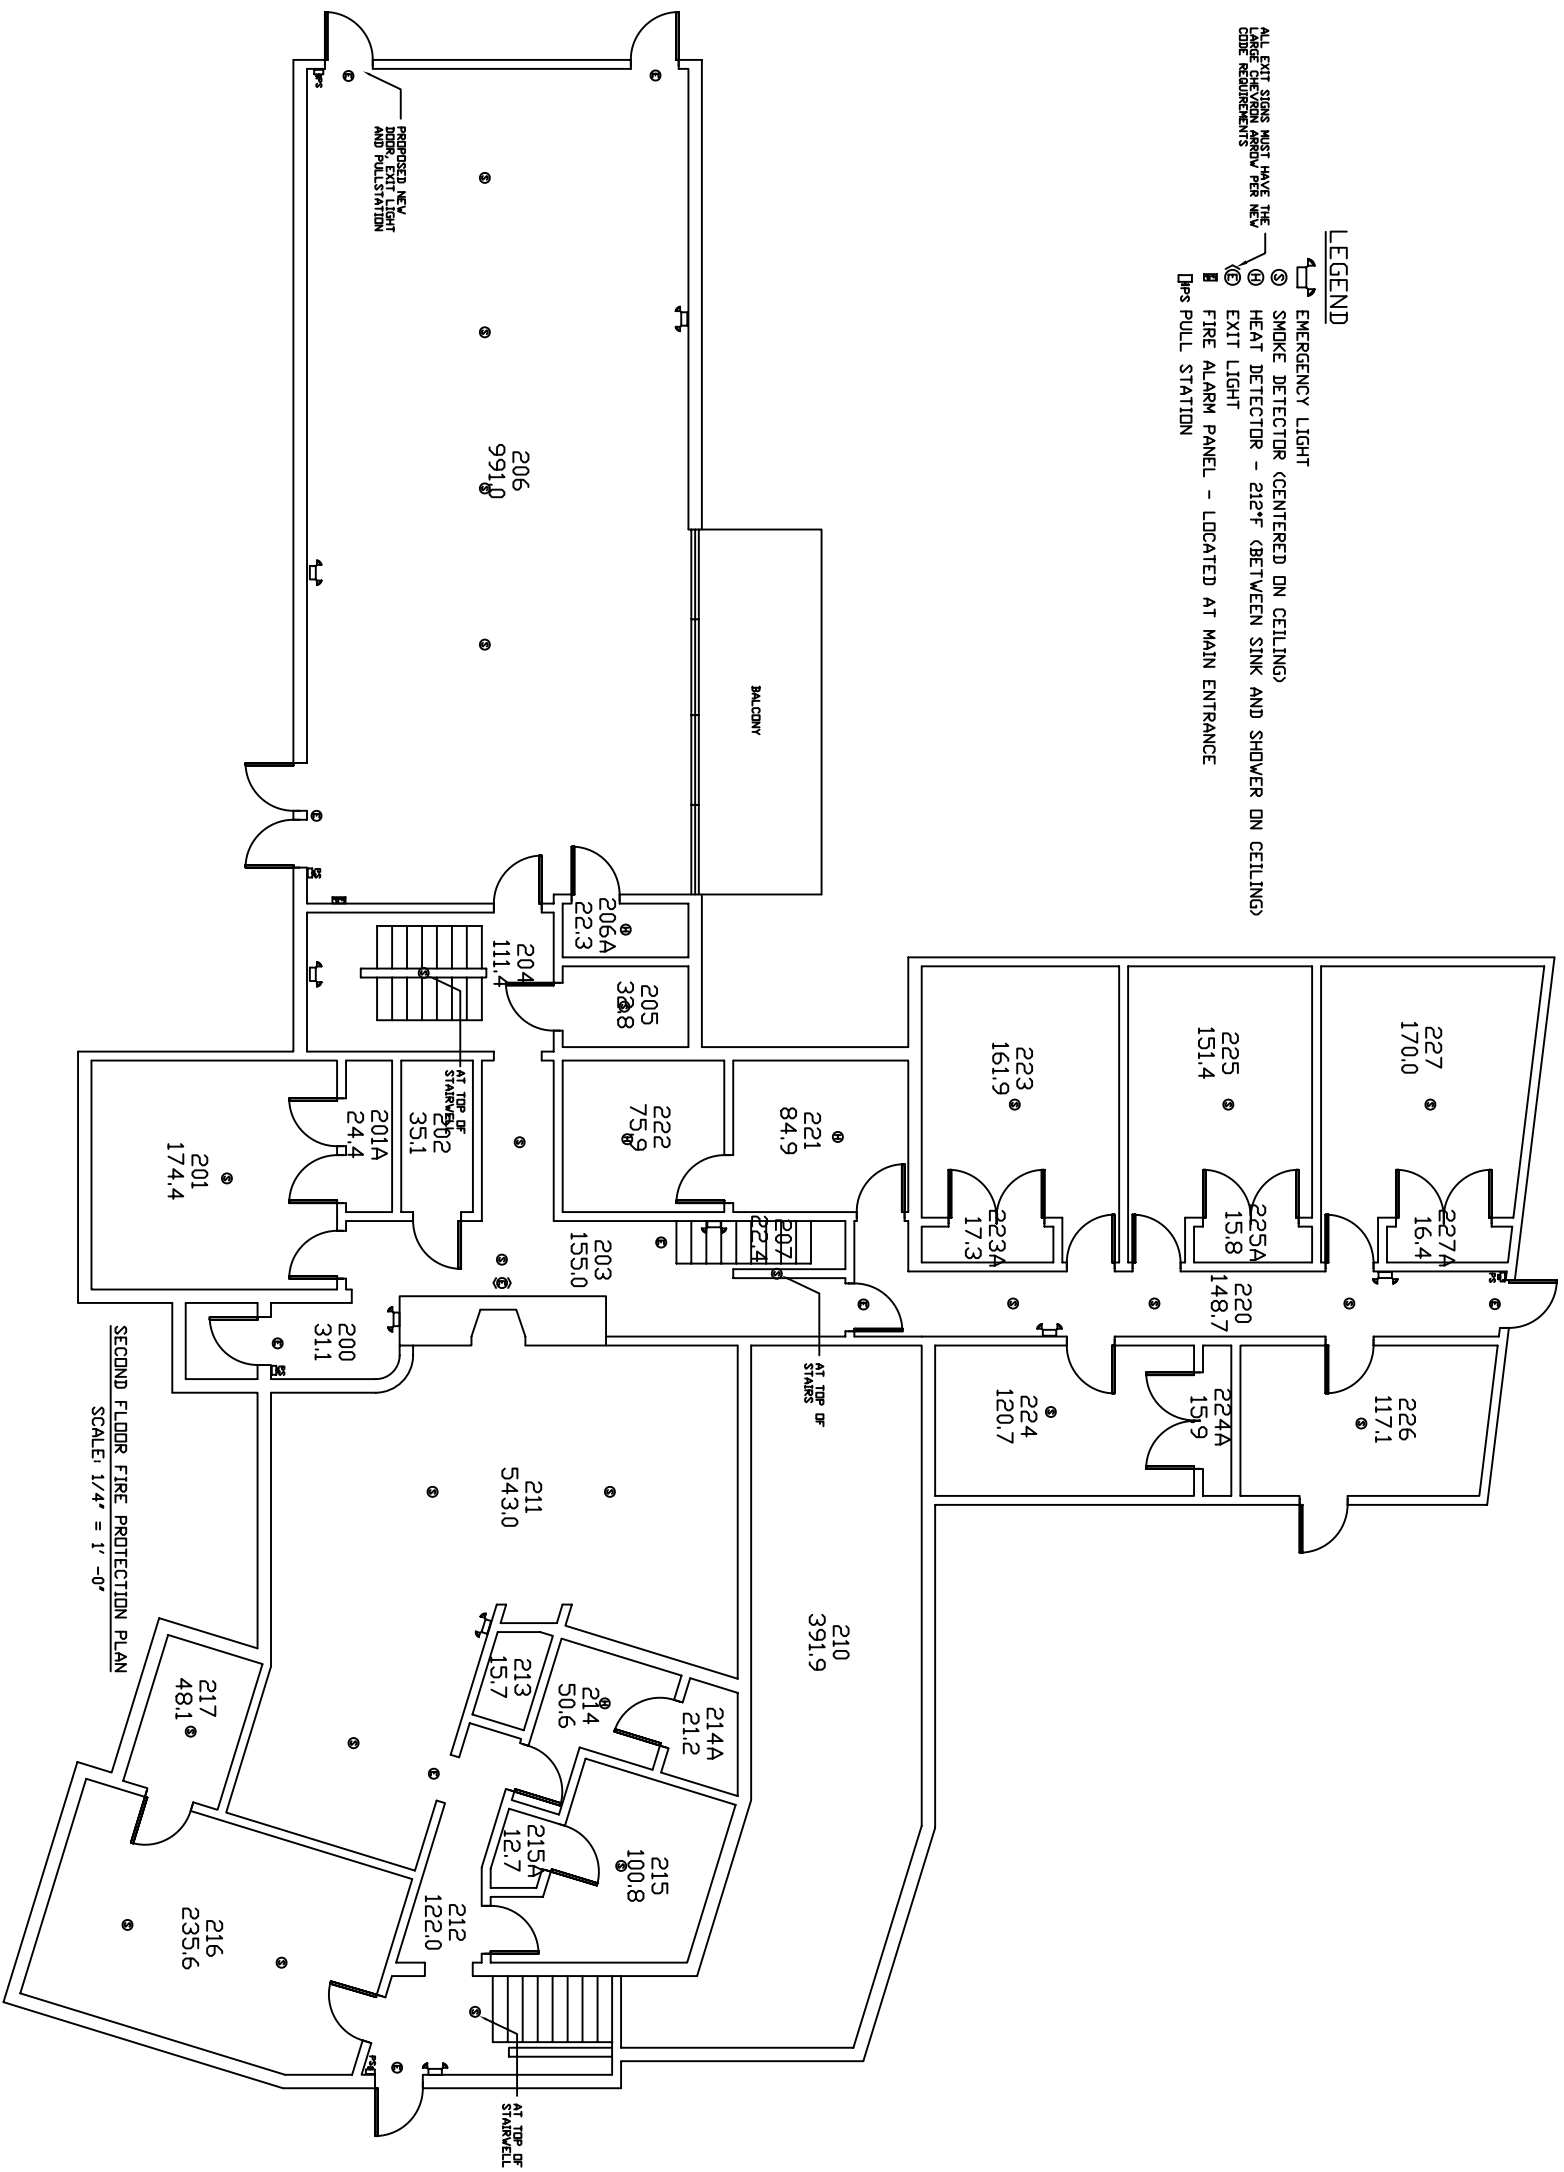

- LEGEND**
- EMERGENCY LIGHT
  - SMOKE DETECTOR (CENTERED ON CEILING)
  - HEAT DETECTOR - 212°F (BETWEEN SINK AND SHOWER ON CEILING)
  - EXIT LIGHT
  - FIRE ALARM PANEL - LOCATED AT MAIN ENTRANCE
  - FIRE PULL STATION
- ALL EXIT SIGNS MUST HAVE THE FOLLOWING REQUIREMENTS:

SECOND FLOOR FIRE PROTECTION PLAN  
SCALE: 1/4" = 1' - 0"