



PLOT PLAN
SCALE: 1"=20'

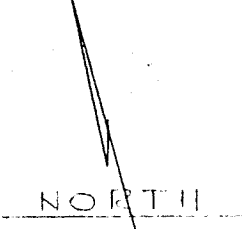


REQUIRED OFFICES:
 15 OFFICES (MINIMUM) 15 OFFICES (MAXIMUM)
 5 OFFICES (MINIMUM) 5 OFFICES (MAXIMUM)
 30 OFFICES (MINIMUM) 30 OFFICES (MAXIMUM)
 150 OFFICES (MINIMUM) 150 OFFICES (MAXIMUM)
 TOTAL
 SPACES PROVIDED: 150 OFFICES (MINIMUM)


Page 3 of 5 Pages

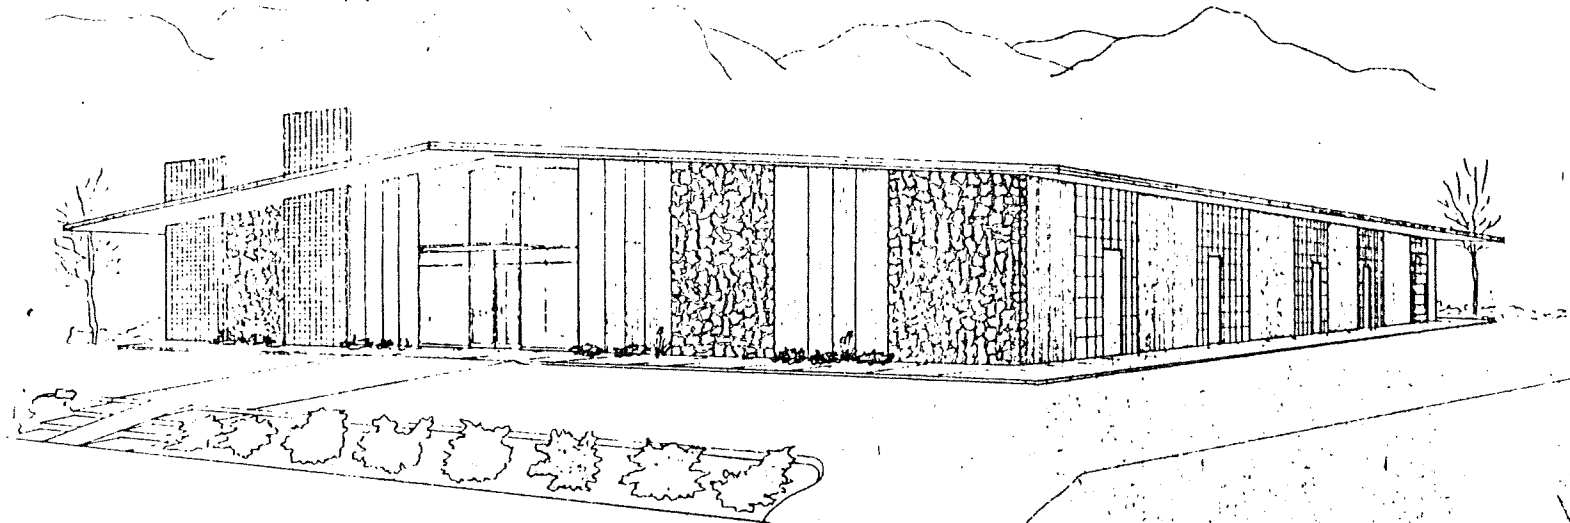

SHEET NO.	TITLE
1	--- PLOT PLAN
2	--- FOUNDATION & BOLT LAYOUT
3	--- FLOOR PLAN
4	--- ELEVATIONS & SECTIONS
5	--- WALL SECTIONS & DETAILS
6	--- CEILING DETAILS
7	--- X-RAY ROOM & PHARMACY
8	--- PLUMBING PLAN
9	--- ELECTRICAL PLAN
10	--- HEATING & COOLING SH#1
11	--- HEATING & COOLING SH#2

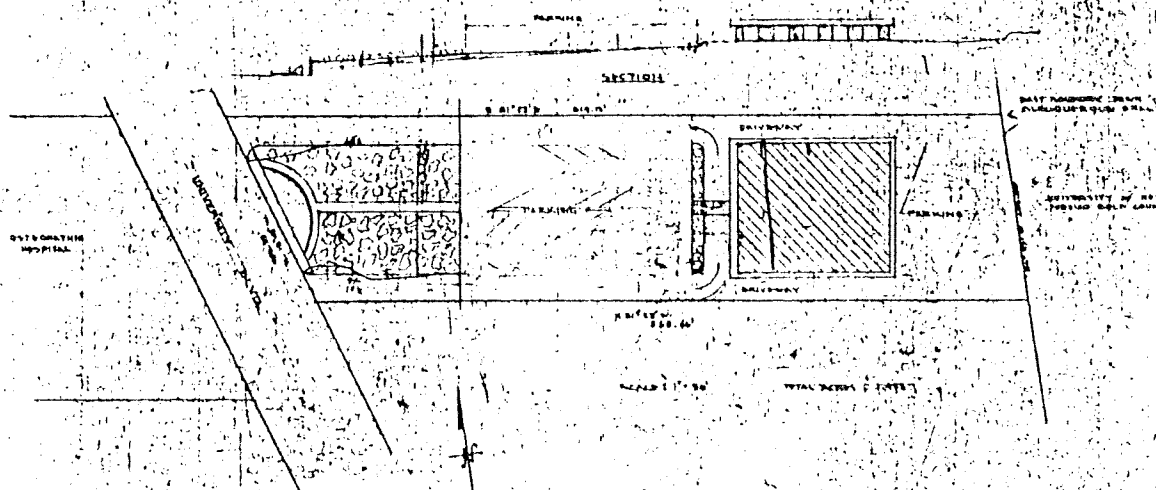

DURA BILT PRODUCTS CO.
 126 WASHINGTON, S.E. PH. 468 7833
 STEEL, STEEL & METALLIC BUILDINGS

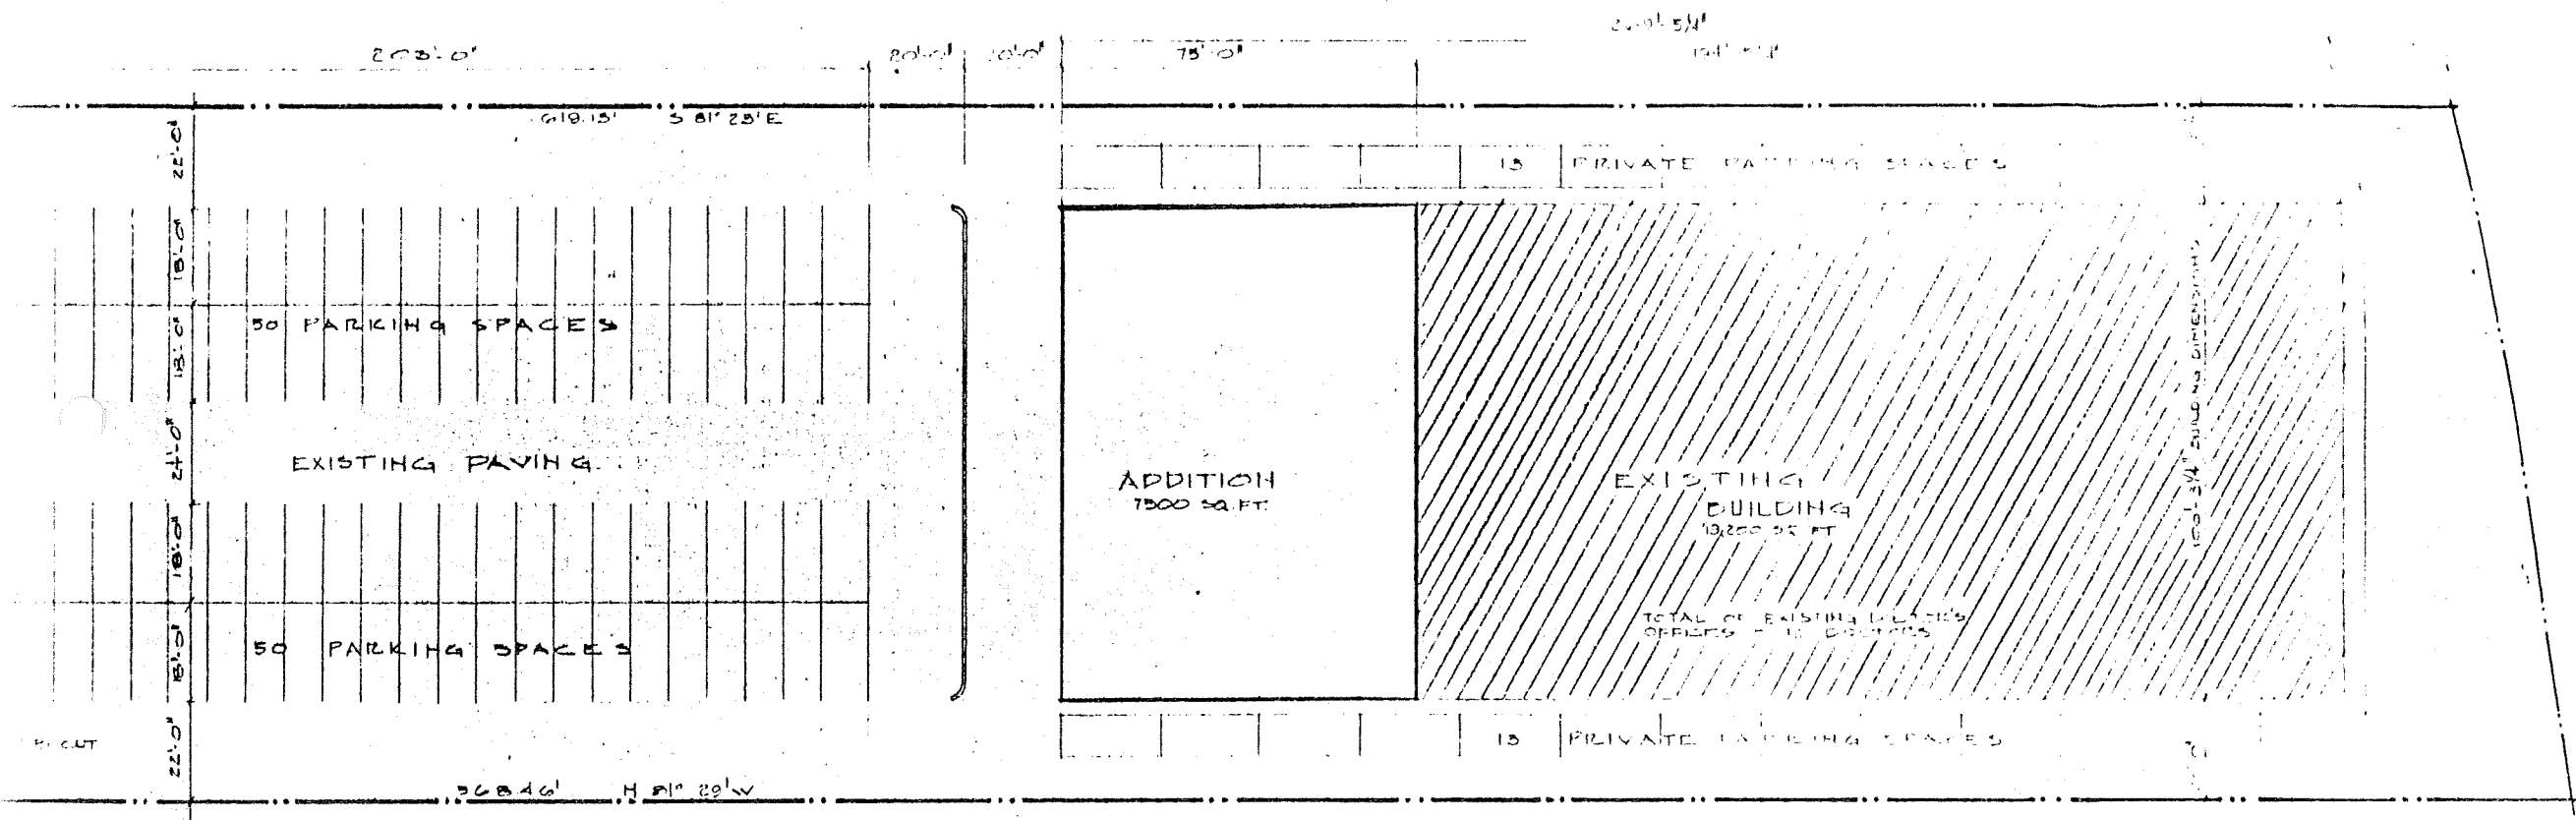

PLOT PLAN
SCALE: 1"=20'

NORTH

12 OFFICES (EXISTING) 12 OFFICES (NEW)
 2 OFFICES (NEW) 2 OFFICES (NEW)
 200 SQ. FT. (EXISTING) 200 SQ. FT. (NEW)
 200 SQ. FT. (NEW) 200 SQ. FT. (NEW)
 SPACES PROVIDED FOR 12 OFFICES
 12 OFFICES (NEW) 12 OFFICES (NEW)
 12 OFFICES (NEW) 12 OFFICES (NEW)